

**KEYED NOTES**

1. PROVIDE (3)20A-1P CIRCUIT BREAKERS IN PANEL HPP521. NEW CIRCUIT BREAKERS TO MATCH EXISTING PANEL/BREAKER CHARACTERISTICS, MANUFACTURER, KAIC, ETC..

**SHEET NOTES**

**MPA MARGULIES PERRUZZI ARCHITECTS**  
 308 Congress Street | Boston, MA 02210 | 617.482.2327 | www.mpp-architects.com  
 Design for the way you work.

**CLIENT INFORMATION**  
**MILL & MAIN RENOVATION**  
**AS CLOCK TOWER OWNER LLC**  
 146 MAIN STREET  
 MAYNARD, MA 01754

**CONSULTANT INFORMATION**

**MEP ENGINEERS**  
**NISSCH ENGINEERING**  
 2 CENTER PLAZA, SUITE 400  
 BOSTON, MA  
 617.258.0665

**LANDSCAPE DESIGN**  
**BROWN, RICHARDSON, & ROWE**  
 12 EDWINE, 3RD FLOOR  
 BOSTON, MA  
 617.542.8552

**GEOTECHNICAL CONSULTANT**  
**HALEY & ALDRICH, INC.**  
 465 MEDFORD STREET, SUITE 2200  
 MEDFORD, MA  
 617.886.7399

**MEP ENGINEERS**  
**AMA CONSULTING ENGINEERS**  
 24 HARTWELL AVE., 3RD FLOOR  
 EDMUNTON, MA 02421  
 781.972.5500

**HARDWARE CONSULTANT**  
**CAMPBELL-MCCABE, INC.**  
 100 W. CENTER ST.  
 MAYNARD, MA 01754  
 781.899.8822


**STRUCTURAL ENGINEER**  
**SIMPSON GUMPERTZ & HEGER**  
 41 SEYON STREET, BLDG 1, SUITE 500  
 BOSTON, MA 02253  
 781.307.9000

**SPECIFICATIONS**  
**KALIN ASSOCIATES**  
 100 WASHINGTON STREET, SUITE 2200  
 BOSTON, MA 02129  
 617.886.7399

**REVISIONS**

NUMBER	DESCRIPTION	DATE

**STAMP**

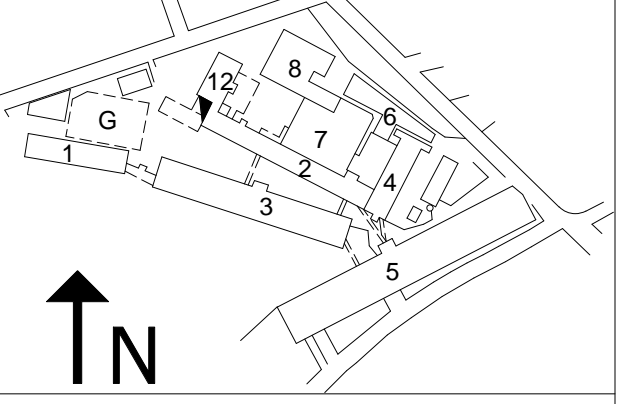

**KEY PLAN**  
 DATE: 10/19/15  
 SCALE: As indicated  
 DRAWN BY: C.L.  
 PROJECT NUMBER: SART15A.00  
 DRAWING TITLE  
**ELECTRICAL BOARDWALK & PIER LIGHTING PLAN**  
**3E-201**  
 DRAWING NUMBER