

1 BUILDING 7 - ELECTRICAL LIGHTING WEST ENTRY PLAN
1/8" = 1'-0"

SHEET NOTES

1. PROVIDE (2)20A-1P CIRCUIT BREAKERS IN EXISTING PANEL. NEW CIRCUIT BREAKERS TO MATCH EXISTING MANUFACTURER, KAIG, ETC..

KEYED NOTES



MARGULIES PERRUZZI ARCHITECTS
308 Congress Street | Boston, MA 02210 | 617.482.2322 | www.mp-architects.com
Design for the way you work.

CLIENT INFORMATION
MILL & MAIN NEW ENTRY OF BLDG 7
146 MAIN STREET
MAYNARD, MA 01754

CONSULTANT INFORMATION
MPE ENGINEERS
MHA CONSULTING ENGINEERS
24 HARTWELL AVE., 3RD FLOOR
LEWINGTON, MA 02421
www.mha-engineers.com
TEL: 781-899-8822
CAMPBELL-MCCABE, INC.
HARDWARE CONSULTANT
MAYNARD, MA 01754
www.campbellmccabe.com
TEL: 781-899-8822
SIMPSON GUMPERTZ & HEGER
STRUCTURAL ENGINEER
MAYNARD, MA 01754
www.sgh.com
TEL: 781-801-9000
CIVIL ENGINEERS
NITSCH ENGINEERING
2 CENTER PLAZA, SUITE 420
BOSTON, MA
TEL: 617-338-6663 - www.nitsch.com
LANDSCAPE DESIGN
BROWN, RICHARDSON, & ROWE
125 STATE ST., 2ND FLOOR
BOSTON, MA 02109
TEL: 617-542-8652 - www.brownrowe.com
GEOTECHNICAL CONSULTANT
HALEY & ALDRICH, INC.
465 MEDFORD STREET, SUITE 2200
MEDFORD, MA 02155
TEL: 617-886-7399 - www.haleyaldrich.com
OWNER
AS CLOCK TOWER OWNER LLC
135 CONN ST., SUITE 200
MAYNARD, MA 02148
TEL: 781-250-8000 - www.asclocktower.com

REVISIONS

NUMBER	DESCRIPTION	DATE

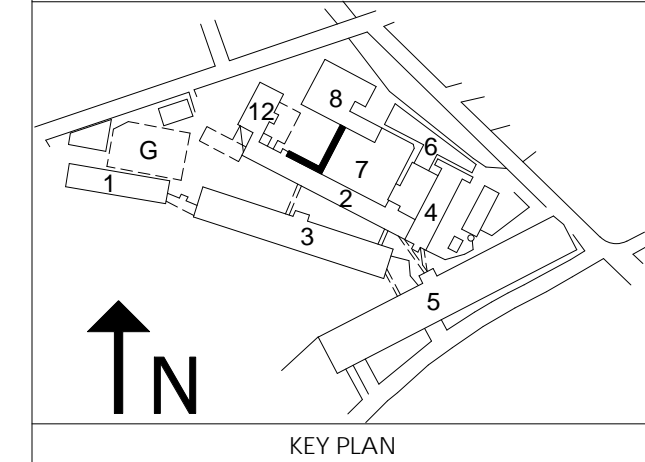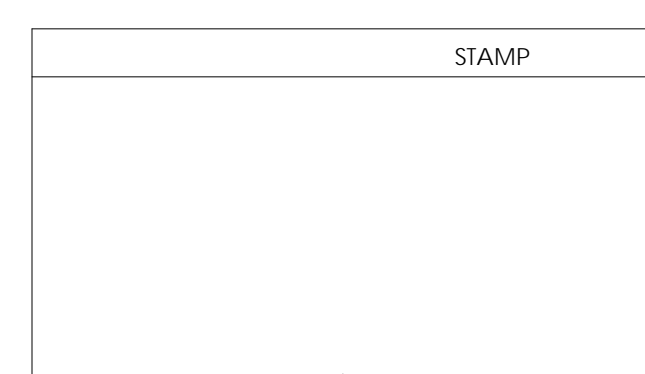

DATE: 10/19/15
SCALE: As Indicated
DRAWN BY: C.R.
PROJECT NUMBER: SART15A.00
DRAWING TITLE:
ELECTRICAL WEST ENTRY LIGHTING PLAN
7E-200
DRAWING NUMBER