


- NOTES:
- HOT-DIP GALVANIZE ALL STEEL, CONNECTORS, AND ANCHOR RODS.
 - PLUG WELD OR FILL WITH METALLIC PUTTY ALL VENT AND DRAIN HOLES.
 - SEAL WELD ALL SEAMS NOT OTHERWISE WELDED.

LEVEL 1 FRAMING PLAN
1/8" = 1'-0"

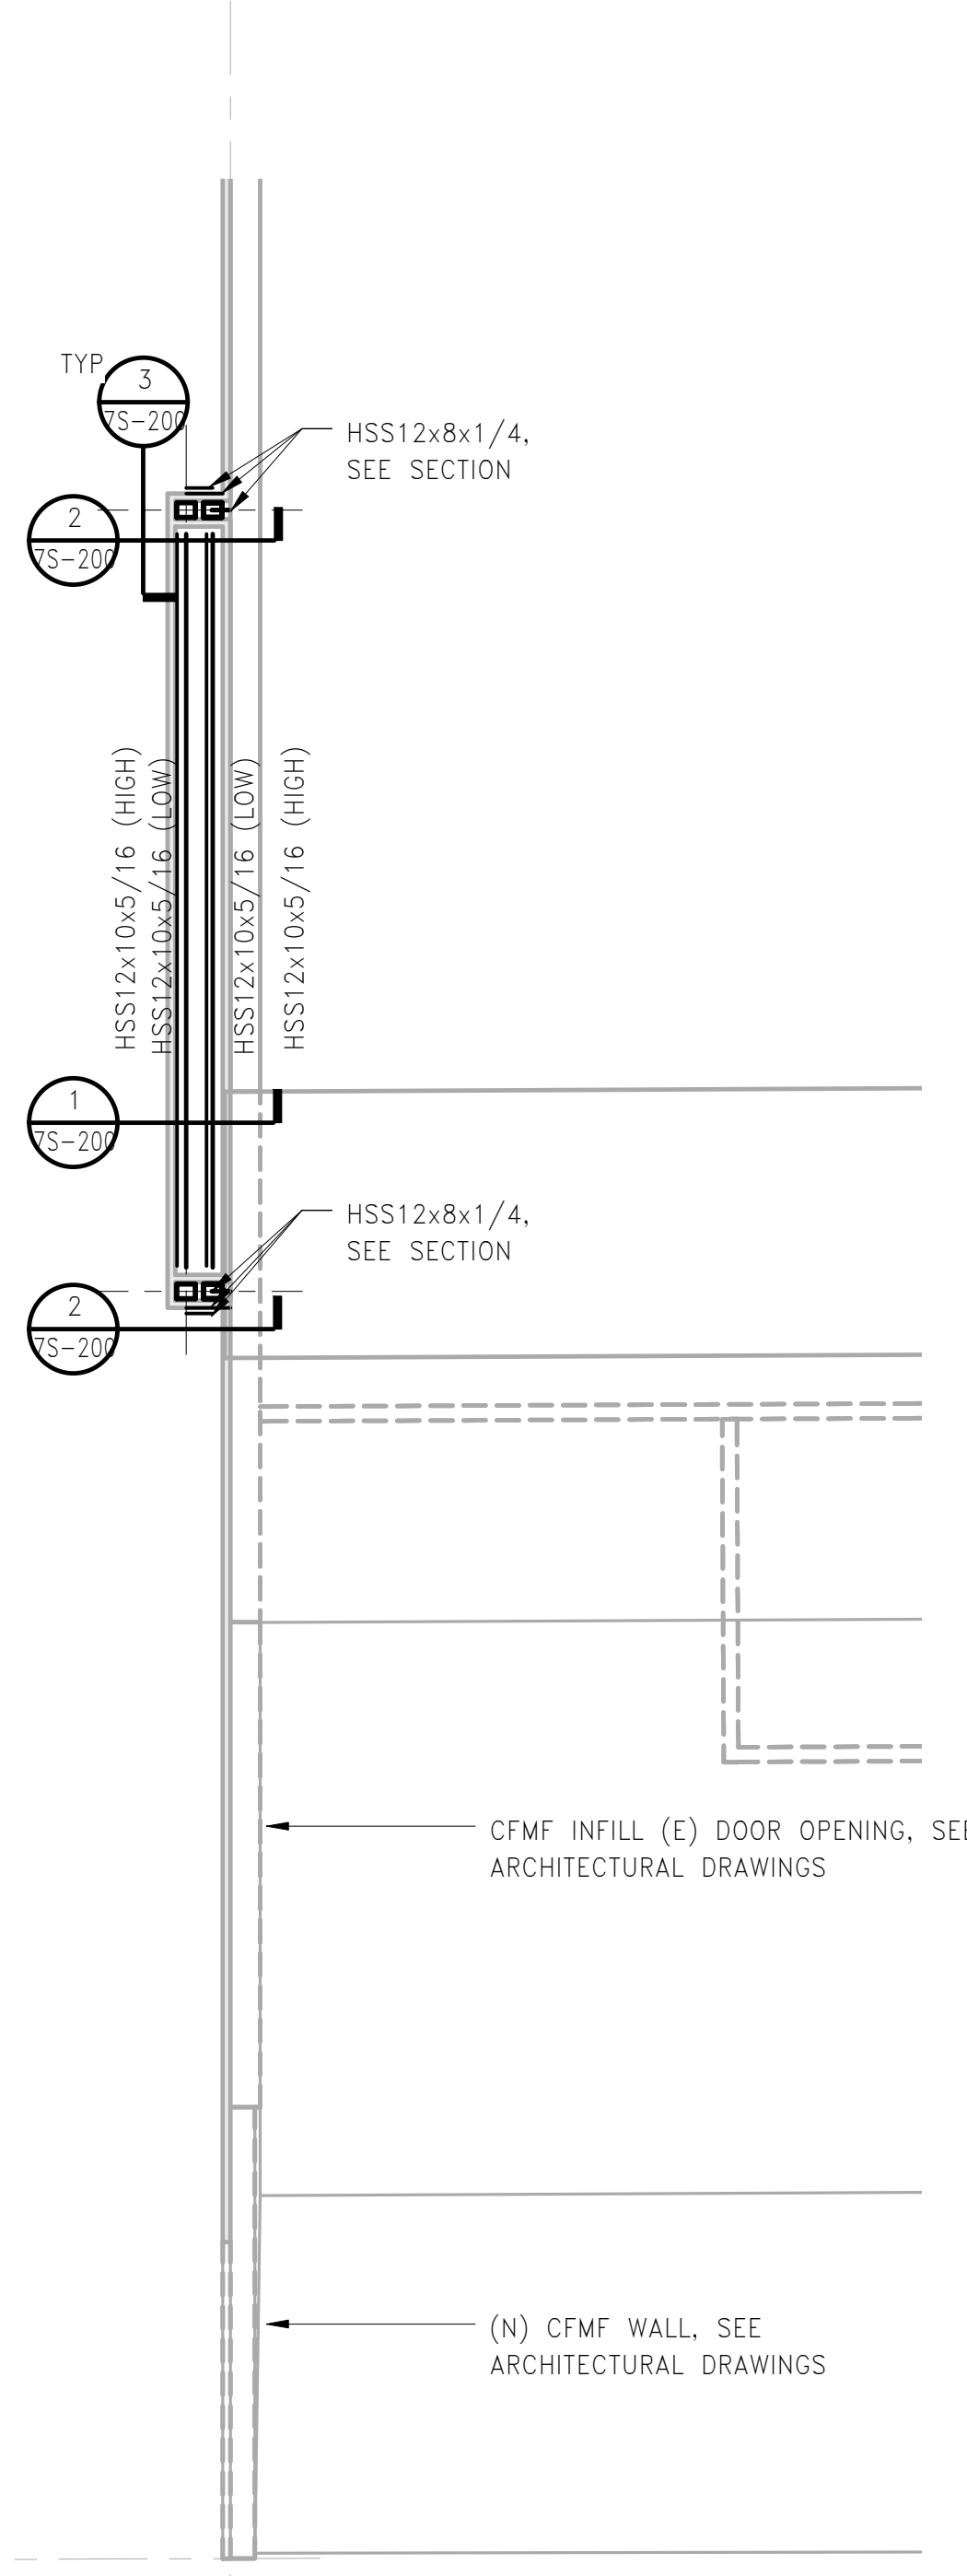

ROOF FRAMING PLAN
1/8" = 1'-0"

MPA MARGULIES PERRUZZI ARCHITECTS
 308 Congress Street | Boston, MA 02210 | 617.482.2322 | www.mpa-architects.com
 Design for the way you work.

CLIENT INFORMATION
AS CLOCK TOWER
 OWNER, LLC c/o
 SARACEN
 PROPERTIES
 MILL & MAIN
 RENOVATION
 PHASE 1
 146 MAIN STREET
 MAYNARD, MA 01751

CONSULTANT INFORMATION

MEP ENGINEERS
WELLS CONSULTING ENGINEERS
 24 HAWTHORNE AVE., 3RD FLOOR
 LYNN, MA 01901
 781.372.3200

HARDWARE CONSULTANT
CAMPBELL-MCCABE, INC.
 1 LOGAN SQUARE PLACE
 LYNN, MA 01901
 781.899.8822

STRUCTURAL ENGINEER
SIMPSON GIMPERTZ & HEGGER
 41 SEYON STREET, BLDG 1, SUITE 500
 WATUHAM, MA 02153
 781.947.9826

CIVIL ENGINEERS
WILSON ENGINEERING
 2 CENTER PLAZA, SUITE 400
 BOSTON, MA 02108
 617.538.0063

LANDSCAPE DESIGN
BROWN, RICHARDSON, & ROWE
 800 WASHINGTON AVE., 3RD FLOOR
 BOSTON, MA 02111
 617.542.8852


GEOTECHNICAL CONSULTANT
HALEY & ALDRICH, INC.
 405 MEDFORD STREET, SUITE 2200
 BOSTON, MA 02129
 617.856.7597

SPECIFICATIONS
KALIN ASSOCIATES
 100 WASHINGTON STREET, #2
 WASHINGTON, MA 01890
 617.964.5177

LIGHTING CONSULTANTS
SLADEN FEINSTEIN INTEG.
 250 WASHINGTON AVE., # 305
 BOSTON, MA 02111
 617.267.9500

REVISIONS		
NUMBER	DESCRIPTION	DATE

STAMP

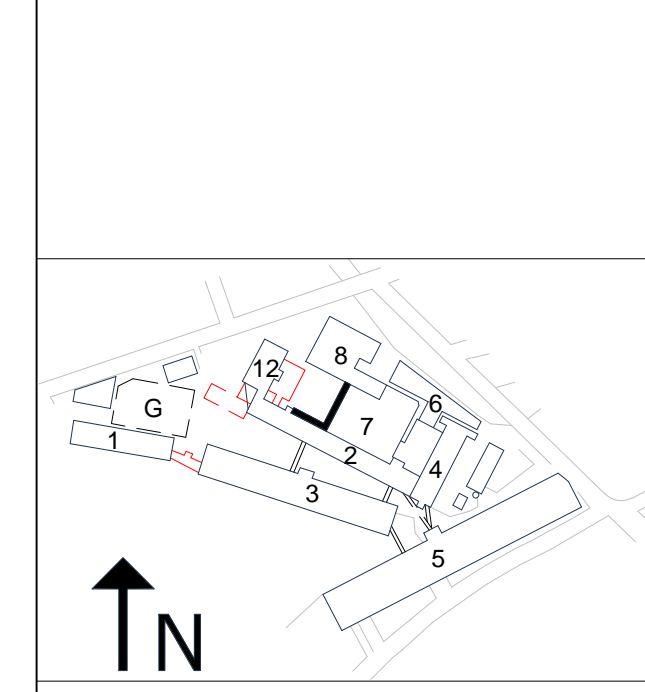

DATE: 10/19/15
 SCALE: 1/8" = 1'-0"
 DRAWN BY: MSS
 PROJECT NUMBER: SAR15A.00
 DRAWING TITLE

FRAMING PLANS
7S-100
 DRAWING NUMBER